
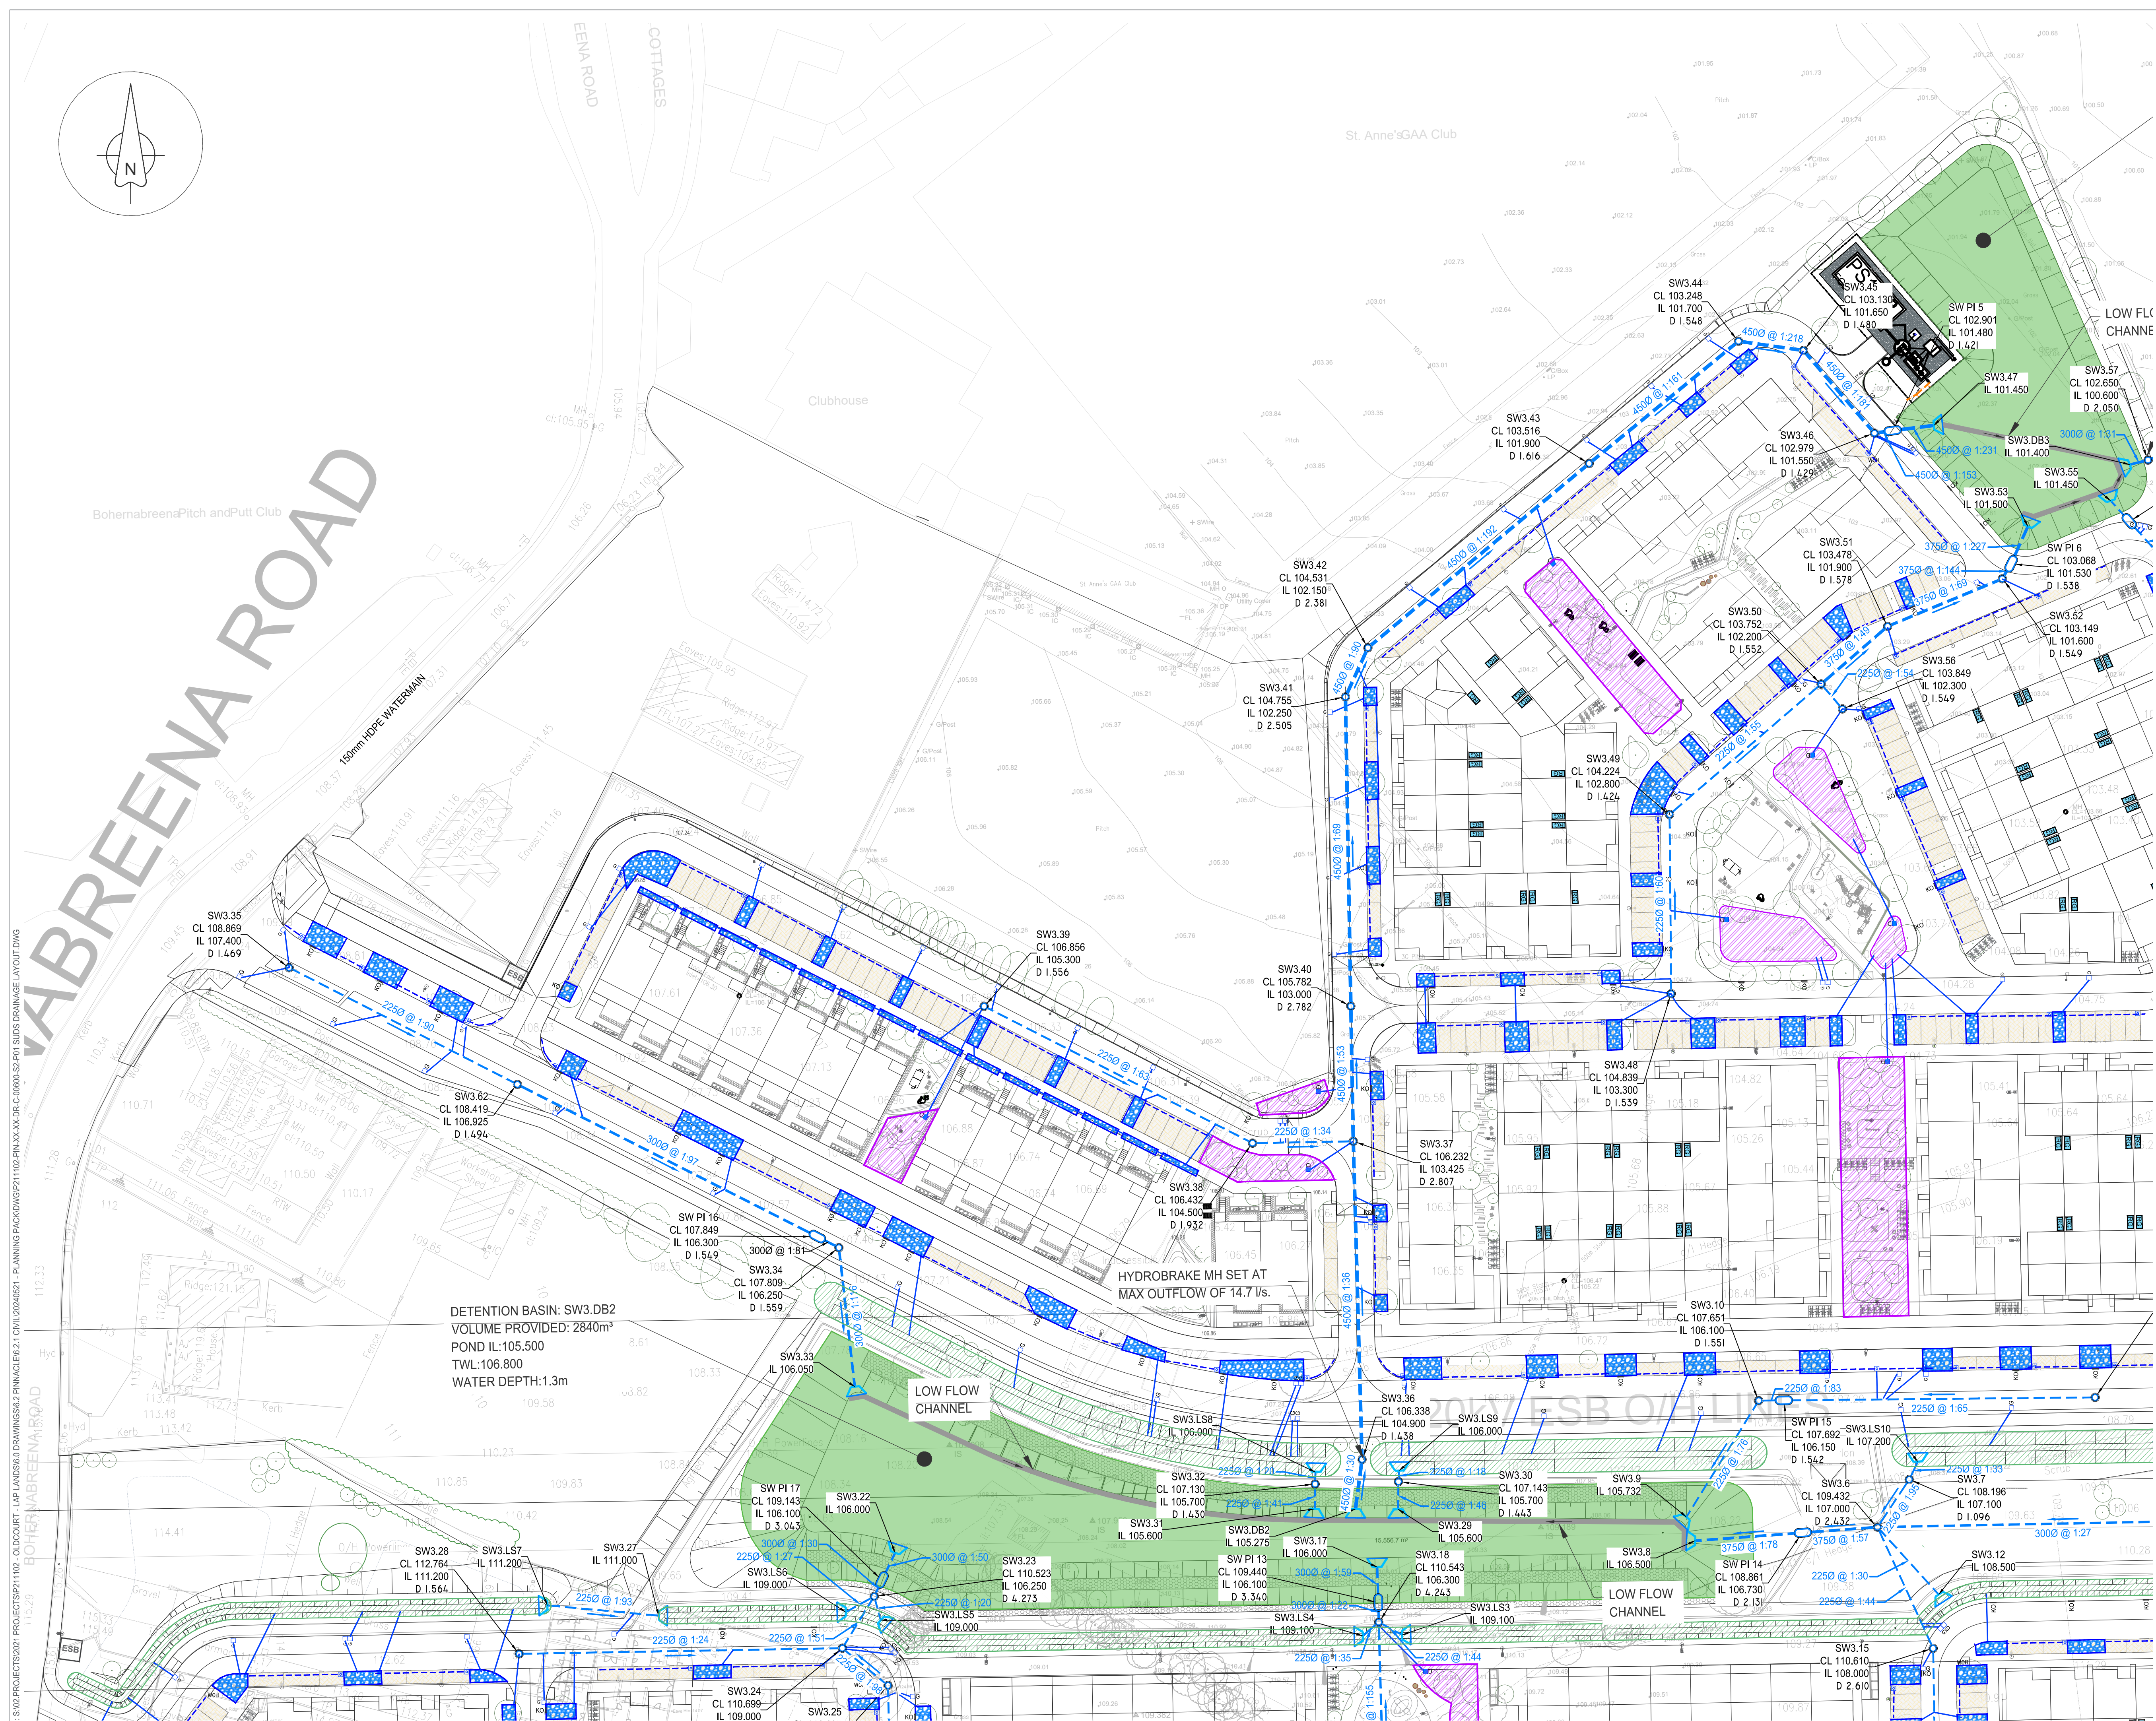


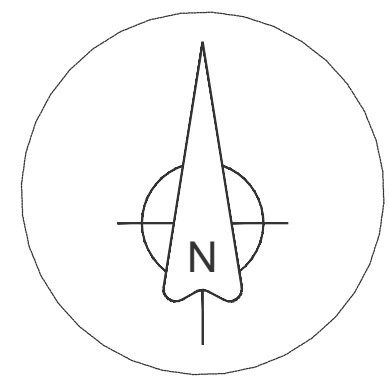

GENERAL NOTES

- DO NOT SCALE THIS DRAWING. WORK ONLY TO FIGURED DIMENSIONS.
- FOR ALL RELEVANT NOTES, REFER TO STRUCTURAL AND CIVIL ENGINEERING PERFORMANCE SPECIFICATION.
- ANY DISCREPANCIES ARE TO BE REPORTED TO PINNACLE CONSULTING ENGINEERS IMMEDIATELY.
- THIS DRAWING IS TO BE READ IN CONJUNCTION WITH ALL OTHER RELEVANT ENGINEERS, ARCHITECTS AND SUB-CONTRACTORS DRAWINGS AND DETAILS.
- THIS DRAWING IS TO BE PRINTED IN COLOUR.
- THIS DRAWING HAS BEEN PREPARED USING THE PROPOSED SITE LAYOUT FROM DAVEY + SMITH ARCHITECTS DRAWING IP00 DATED 16/08/24.
- EXISTING SITE AND LEVEL INFORMATION TAKEN FROM LAND SURVEYS TOPOGRAPHICAL SURVEY DRAWING D1728F2D DATED 04/10/06.
- THIS DRAWING IS NOT TO BE USED FOR CONSTRUCTION PURPOSES UNLESS EXPRESSLY STATED.

LEGEND

- PROPOSED SURFACE WATER SEWER
- EXISTING SURFACE WATER SEWER
- SURFACE WATER SEWER TO BE ABANDONED
- 150mmØ UPVC SURFACE WATER PIPE
- SURFACE WATER FIN DRAIN
- SURFACE WATER LAND DRAIN
- DRAINAGE CHANNEL
- ROAD GULLY
- RAINFALL DOWNPIPE
- SW INSPECTION CHAMBER WITH SILT TRAP
- PROPOSED LEVEL
- EXISTING LEVEL
- 500mm KERB OPENING/ DROPPED KERB
- RAIN GARDEN GULLY OVERFLOW
- DETENTION BASIN
- GREEN ROOF
- TRAFFICKED PERMEABLE PAVING
- NON TRAFFICKED PERMEABLE PAVING
- 300mm DEEP RAIN GARDEN
- 900mm DEEP BIO RETENTION TREE PIT
- SUDS DRAINAGE SWALE
- RAINGARDEN PLANTER BOX

SCALE 1:500
0 5 10 15 20 25m
DIMENSIONS IN METRES

P01 ISSUED FOR PLANNING FJVR JB 02/09/24

REV	DESCRIPTION	BY	CHK/ APP	DATE
-----	-------------	----	----------	------

CLIENT

CAPAMI LTD

PROJECT
OLDCOURT LRD

DRAWING TITLE
SUDS DRAINAGE LAYOUT
SHEET 1 OF 6

PINNACLE
CONSULTING ENGINEERS

GROSVENOR COURT,
67A PATRICK STREET,
DUN LAOGHAIRE,
COUNTY DUBLIN,
IRELAND, A66 W3V7
NORWICH ■ WELWYN GARDEN CITY ■ LONDON ■ THE HAGUE ■ FRANKFURT

TELEPHONE: +353 1 2311041

DRAWING STATUS

PLANNING

SCALE @ A1	DATE	DRAWN BY	CHECKED	APPROVED
------------	------	----------	---------	----------

1:500	2024/04/28	FJVR	JB	SOR
-------	------------	------	----	-----

DRG NO.	REV
---------	-----

P211102-PIN-XX-XX-DR-C-00601-S2	P01
---------------------------------	-----

COPYRIGHT PINNACLE